


**Notes:**  
 1. Ordnance Survey Ireland Licence No. EN 0002815  
 © Ordnance Survey Ireland/ Government of Ireland  
 2. Topographical survey to ITM grid reference and main head ordnance datum

**Proposed Road & Services - Section B-B**  
 Scale: 1:50

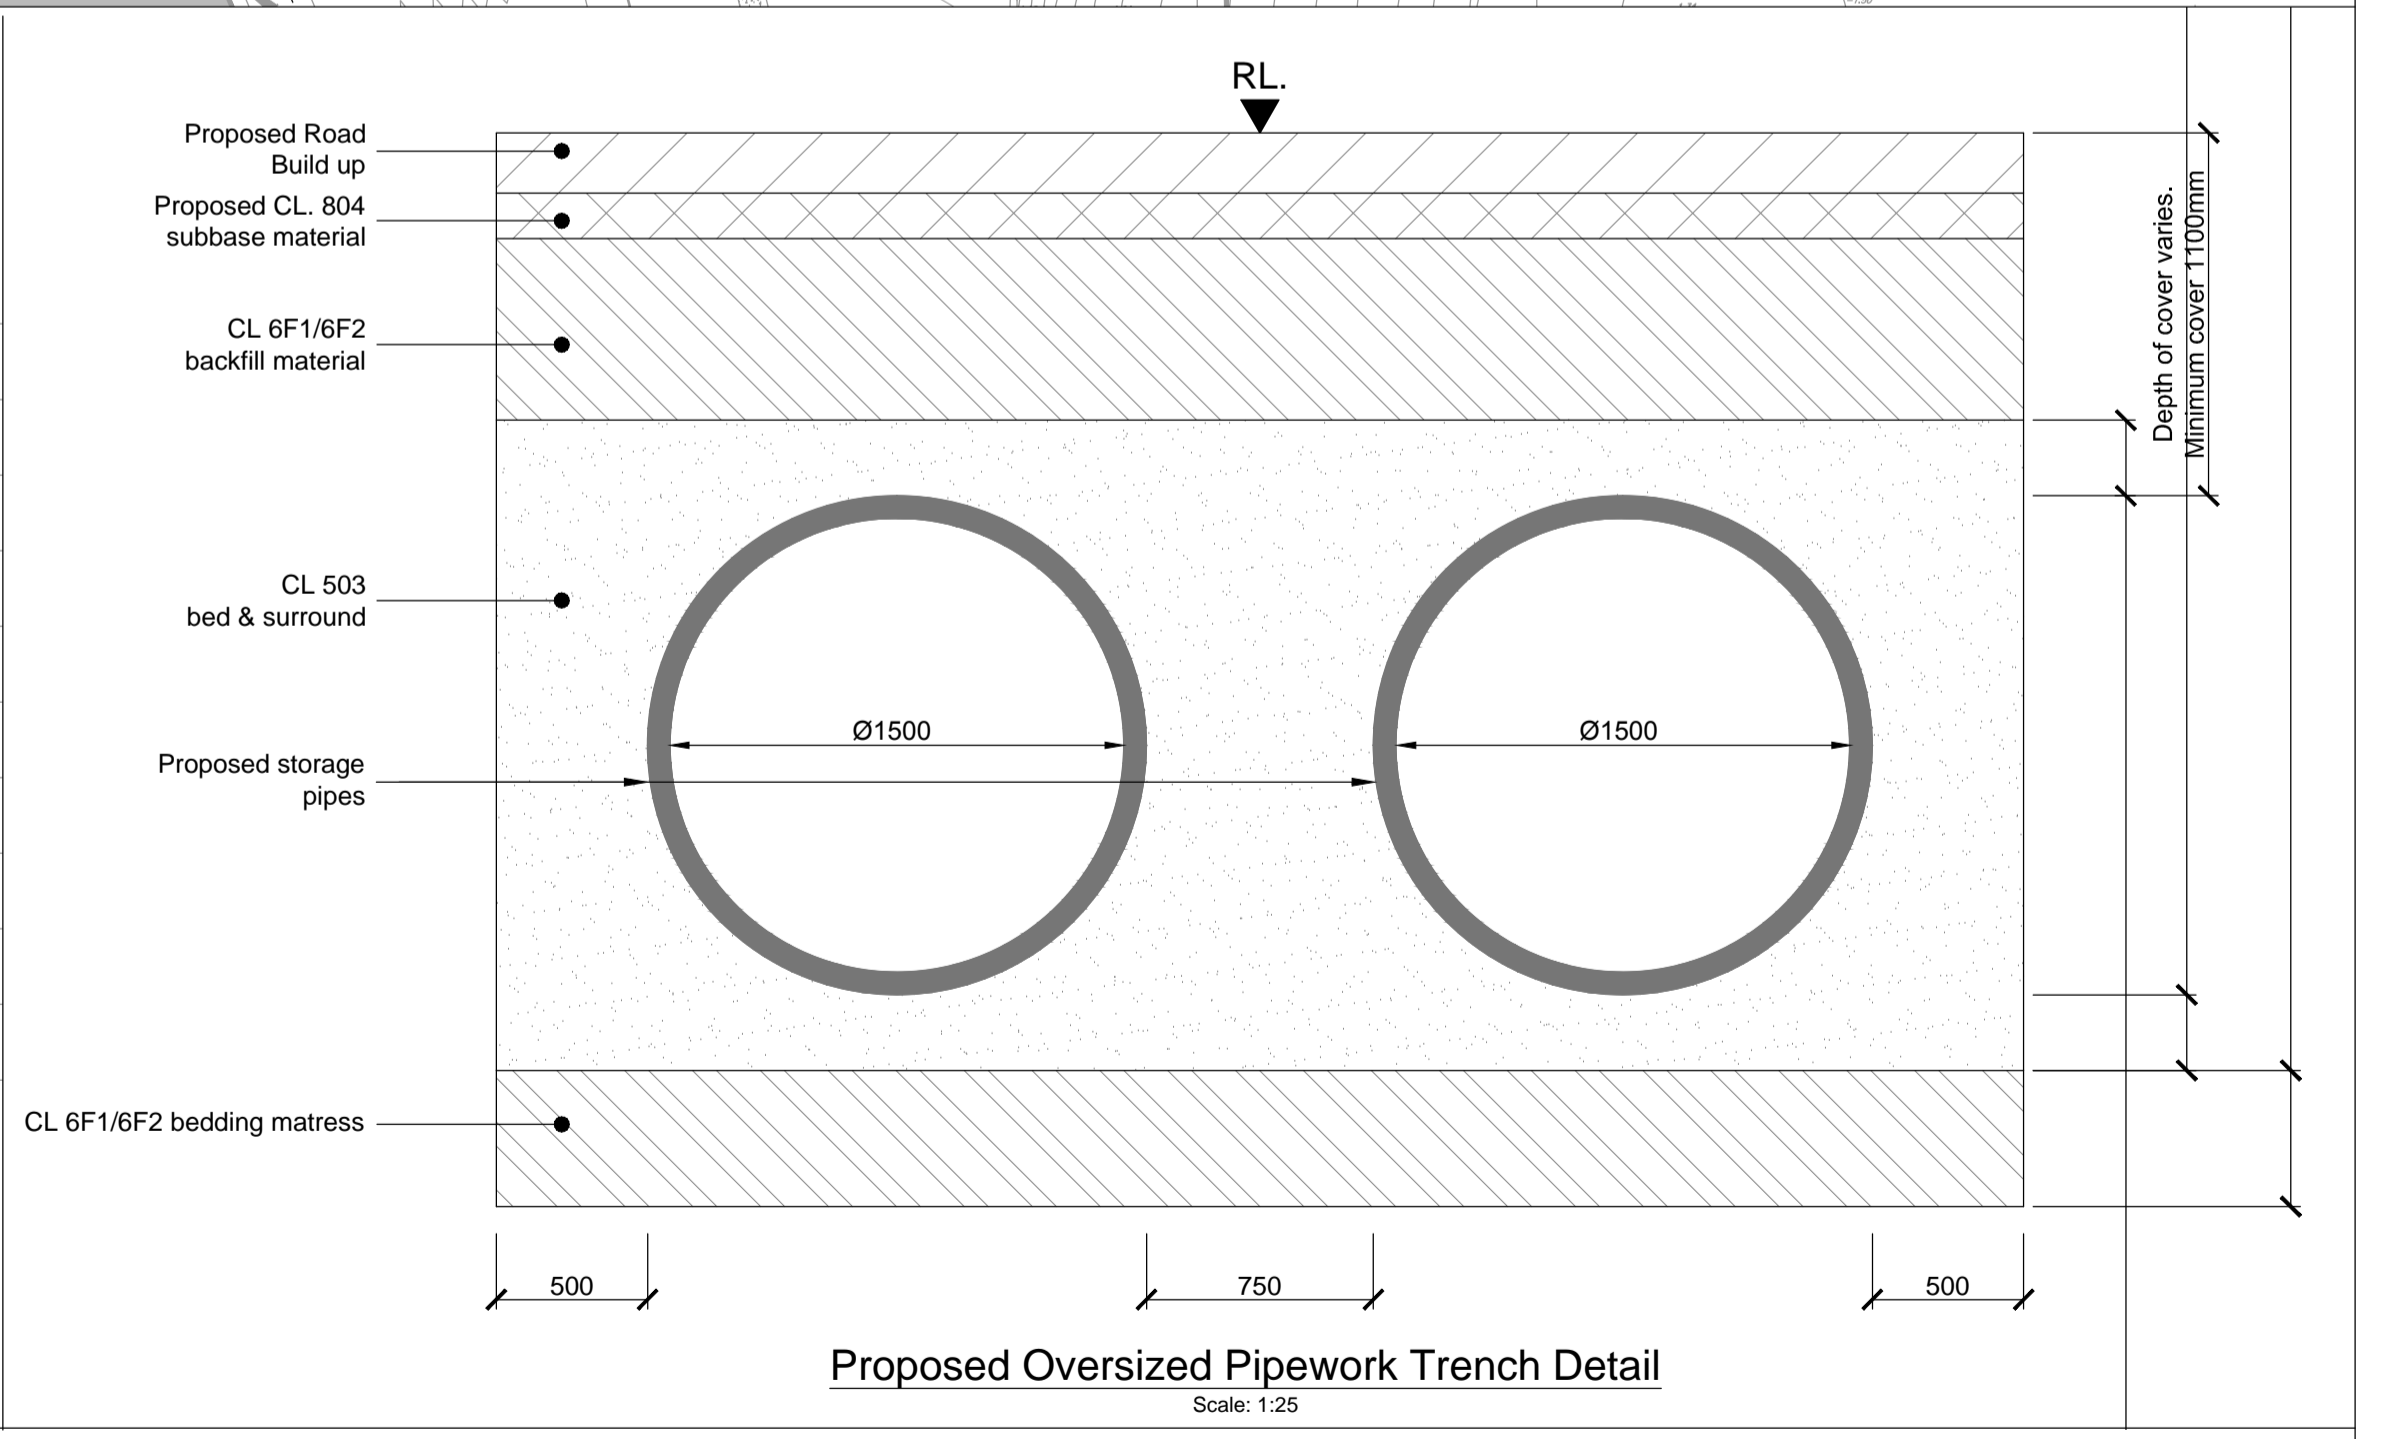

**Legend:**

Proposed 1500mmØ Pipe		Existing 450mmØ Drain to be Retained	
Proposed Carrier Drain		Existing 450mmØ Drain to be Removed	
Proposed Surface Water Concrete Channel		Existing 300mmØ Drain to be Retained	
Proposed Road Gullies		Existing 300mmØ Drain to be Removed	
Proposed Hydrocarbon Interceptor			

PL1	11/12/15	JB	DT	JMac
Issued for Planning				
Rev	Date	By	Chkd	Appd

**ARUP**  
 15 Oliver Plunkett Street  
 Cork, Ireland  
 Tel +353 (0)21 427 7670 Fax +353 (0)21 427 2345  
 www.arup.com

Client  
**INDAVER**

Project Title  
**Ringaskiddy Resource Recovery Centre**

Drawing Title  
**Proposed Surface Water Road Drainage Layout Sheet 2 of 2**

Scale at A1: 1:500 u.n.o.  
 Role: Site Infrastructure  
 Suitability: Planning  
 Arup Job No: **238129-00**  
 Name: **PL1**  
 C-000-014